
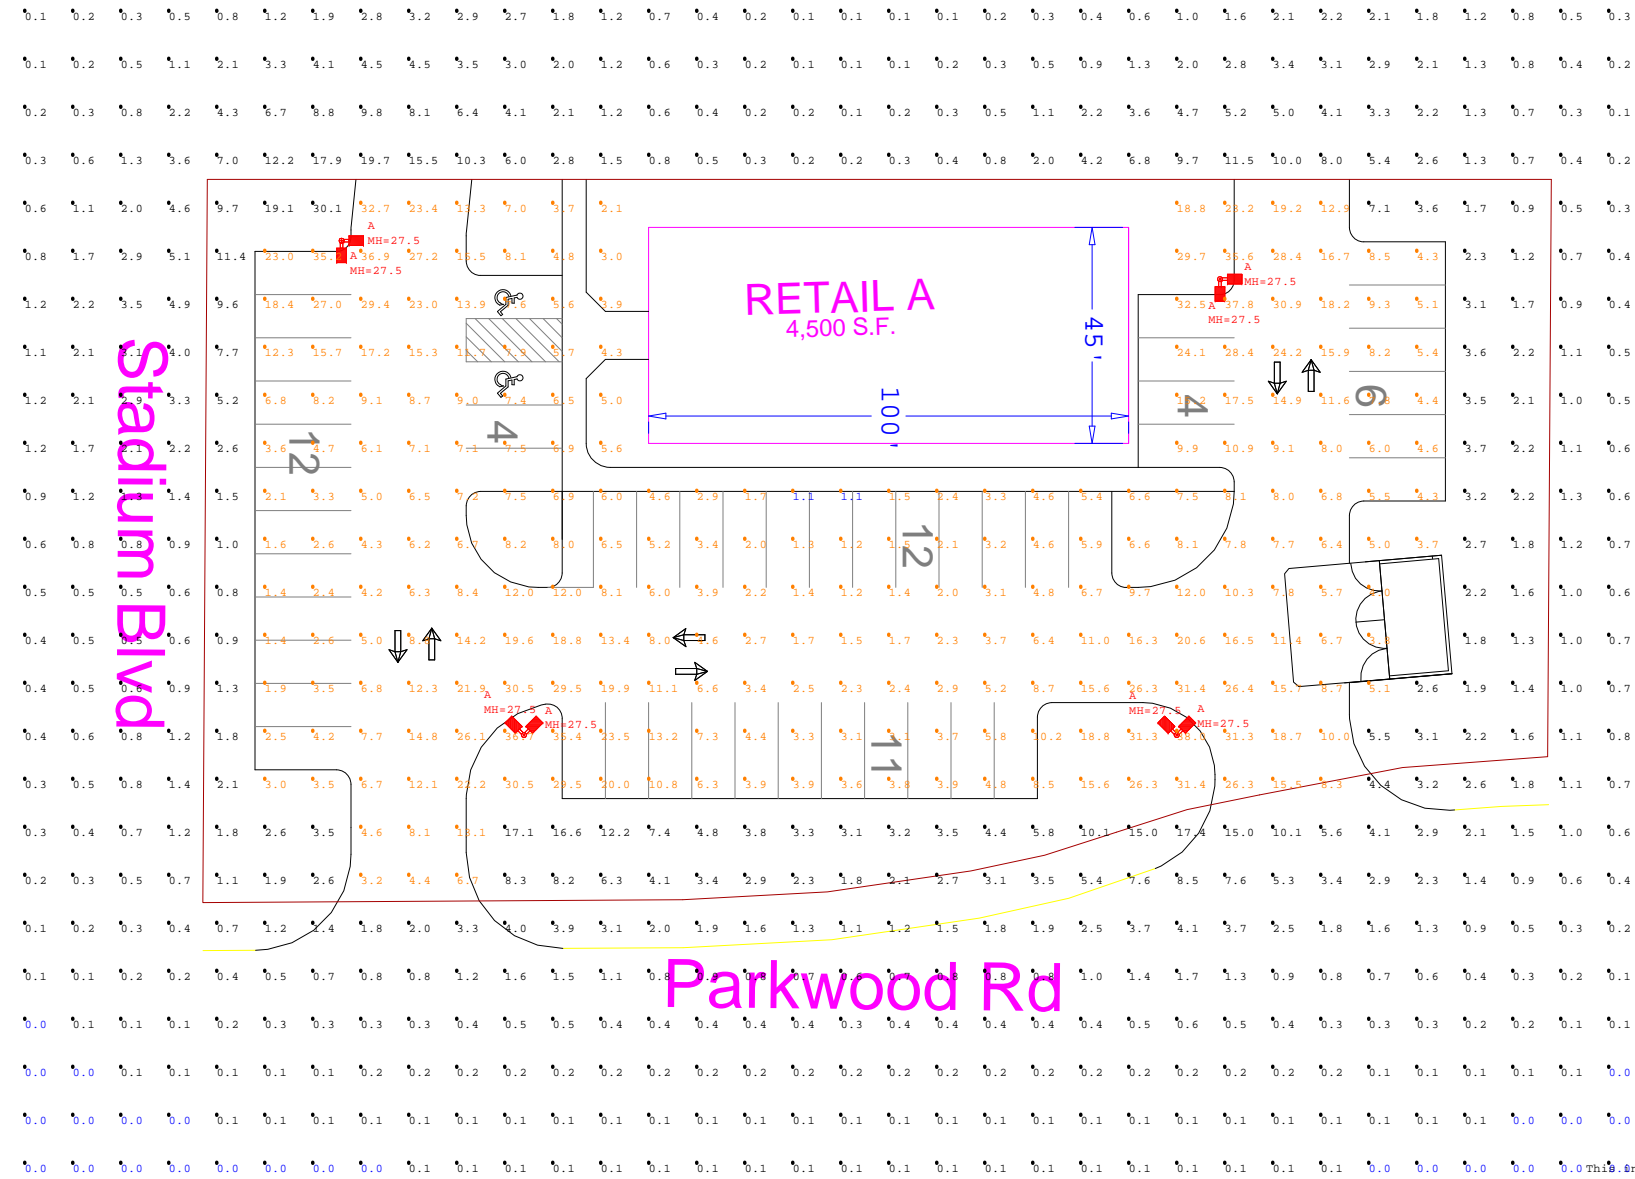



Calculation Summary					
Label	Avg	Max	Min	Avg/Min	Max/Min
Parking lot	10.61	38.0	1.1	9.65	34.55
Spill	0.69	30.1	0.0	N.A.	N.A.

Luminaire Schedule					
Qty	Label	Description	Lumens	LLF	Symbol
8	A	CSB3-1000MH-QT-L	107800	0.750	



Scale: 1 inch= 40 Ft.

This information is confidential and the sole property of Juno Lighting Group. It is not to be reproduced or distributed to others without the written permission of Juno Lighting Group.

	220 Chrysler Drive Brampton, Ontario L6S 6B6 Tel: (905) 792-7335 email: ljorge@ junolightinggroup.com	Client:  MICHELLE RILEY	Project: VERIZON WIRELESS JONESBORO AR PARKING LOT LIGHTING MAINTAINED HORIZONTAL FC SHOWN AT GRADE LEVEL OSRAM M1000/U	Scale:  Date: 2012-08-22  Project No: 12-235-AP1 (2924)  Drawn by: LJ	The calculation and results thereof, shown in this report, are based on information provided by the customer. The output figures are only as accurate as the input data. Therefore design parameters such as room reflectances, size, mounting height, depreciation factors, orientation and tilt must be verified. Juno Lighting Group disclaims all implied warranties with regard to actual installed light levels as compared to those calculated based on inaccurate or incomplete data
--	--	-------------------------------	--	--	---