




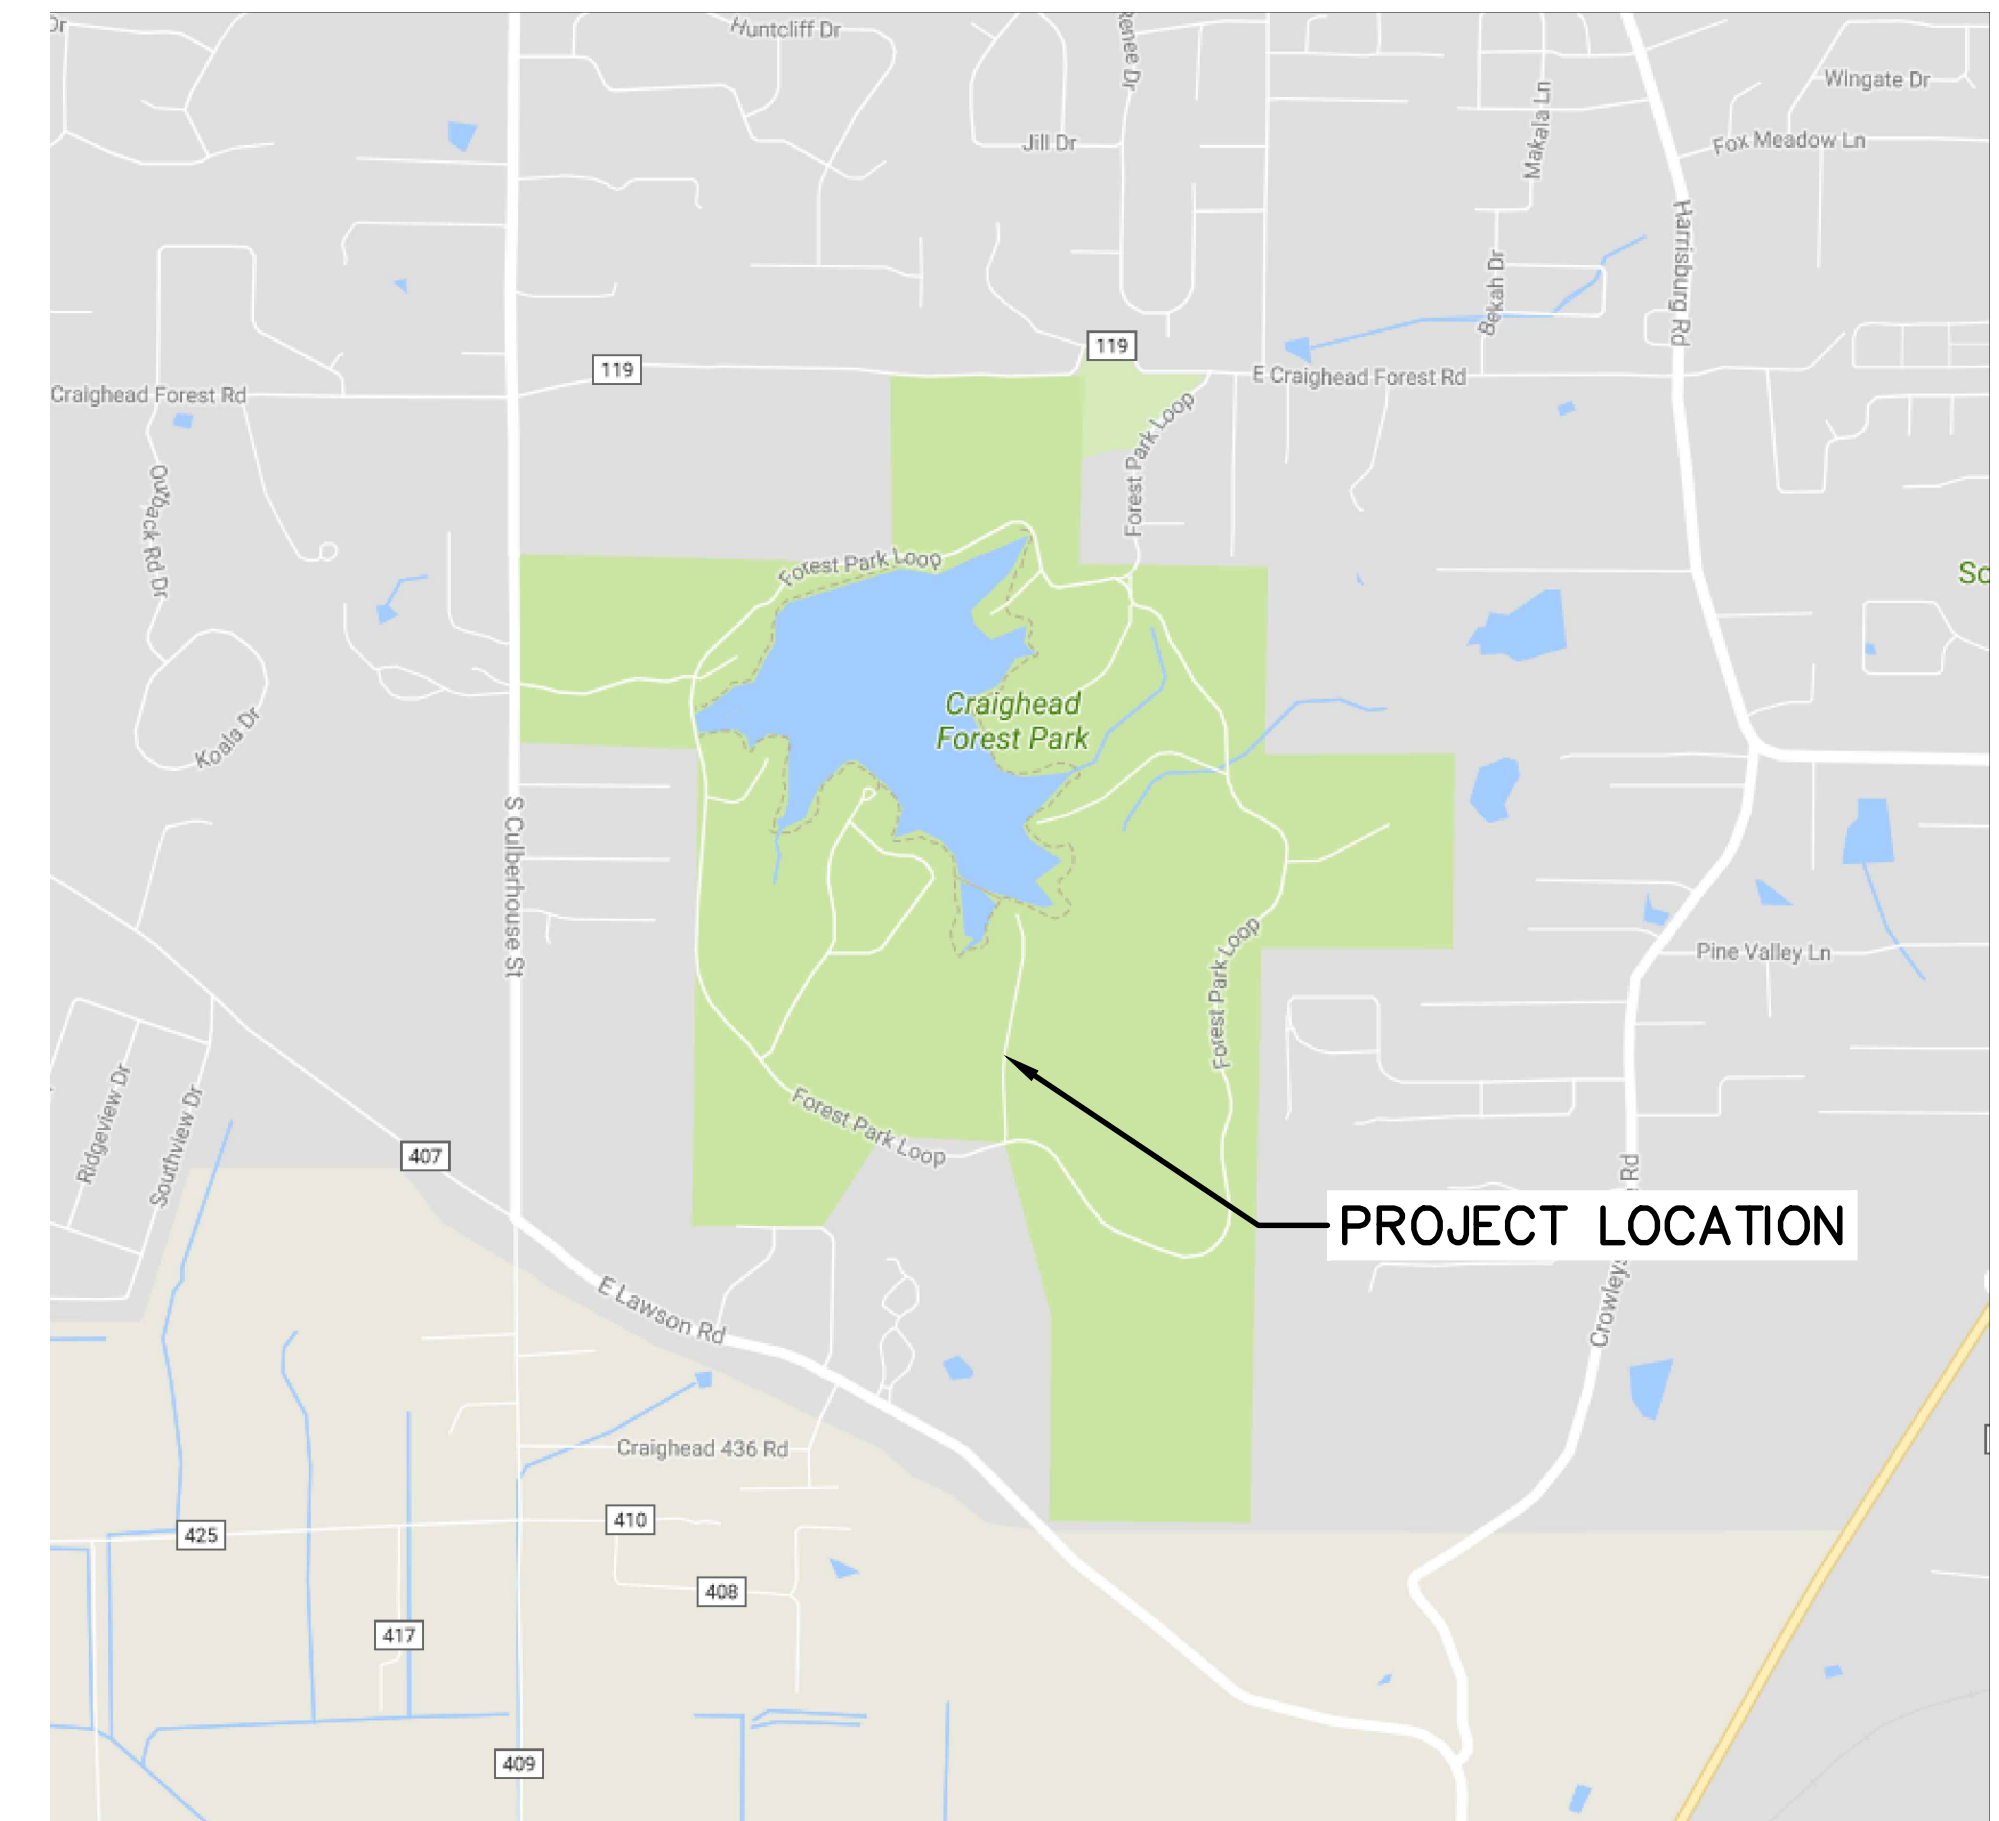

SITE PLAN

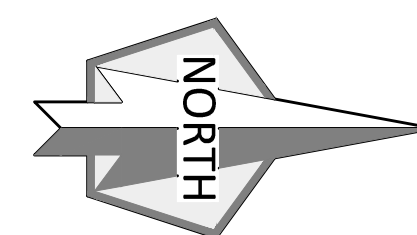

VICINITY MAP - NOT TO SCALE

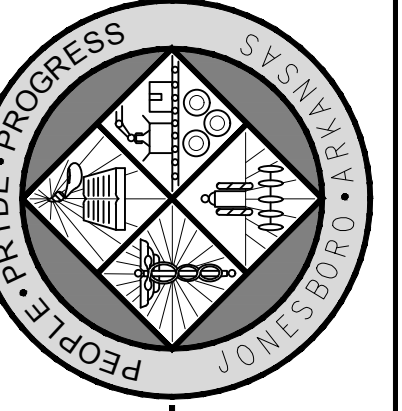

Engineering Department
 Phone: (870) 832-2438
 P.O. Box 1845
 307 Vine Street
 Jonesboro, AR 72401
 Email: engineer@jonesboro.org

City of
Jonesboro
 ARKANSAS

CRAIGHEAD FOREST PUMPTRACK

REVISIONS

DATE	BY	DESCRIPTION

DRAWING INFO.

DRAWN BY:	memorris
DATE:	7/31/17
SCALE:	NOTED
JOB NO.:	GRANT
CAD NO.:	GRANT DEPT

SITE PLAN

SHEET NUMBER:

1 of **1**

