



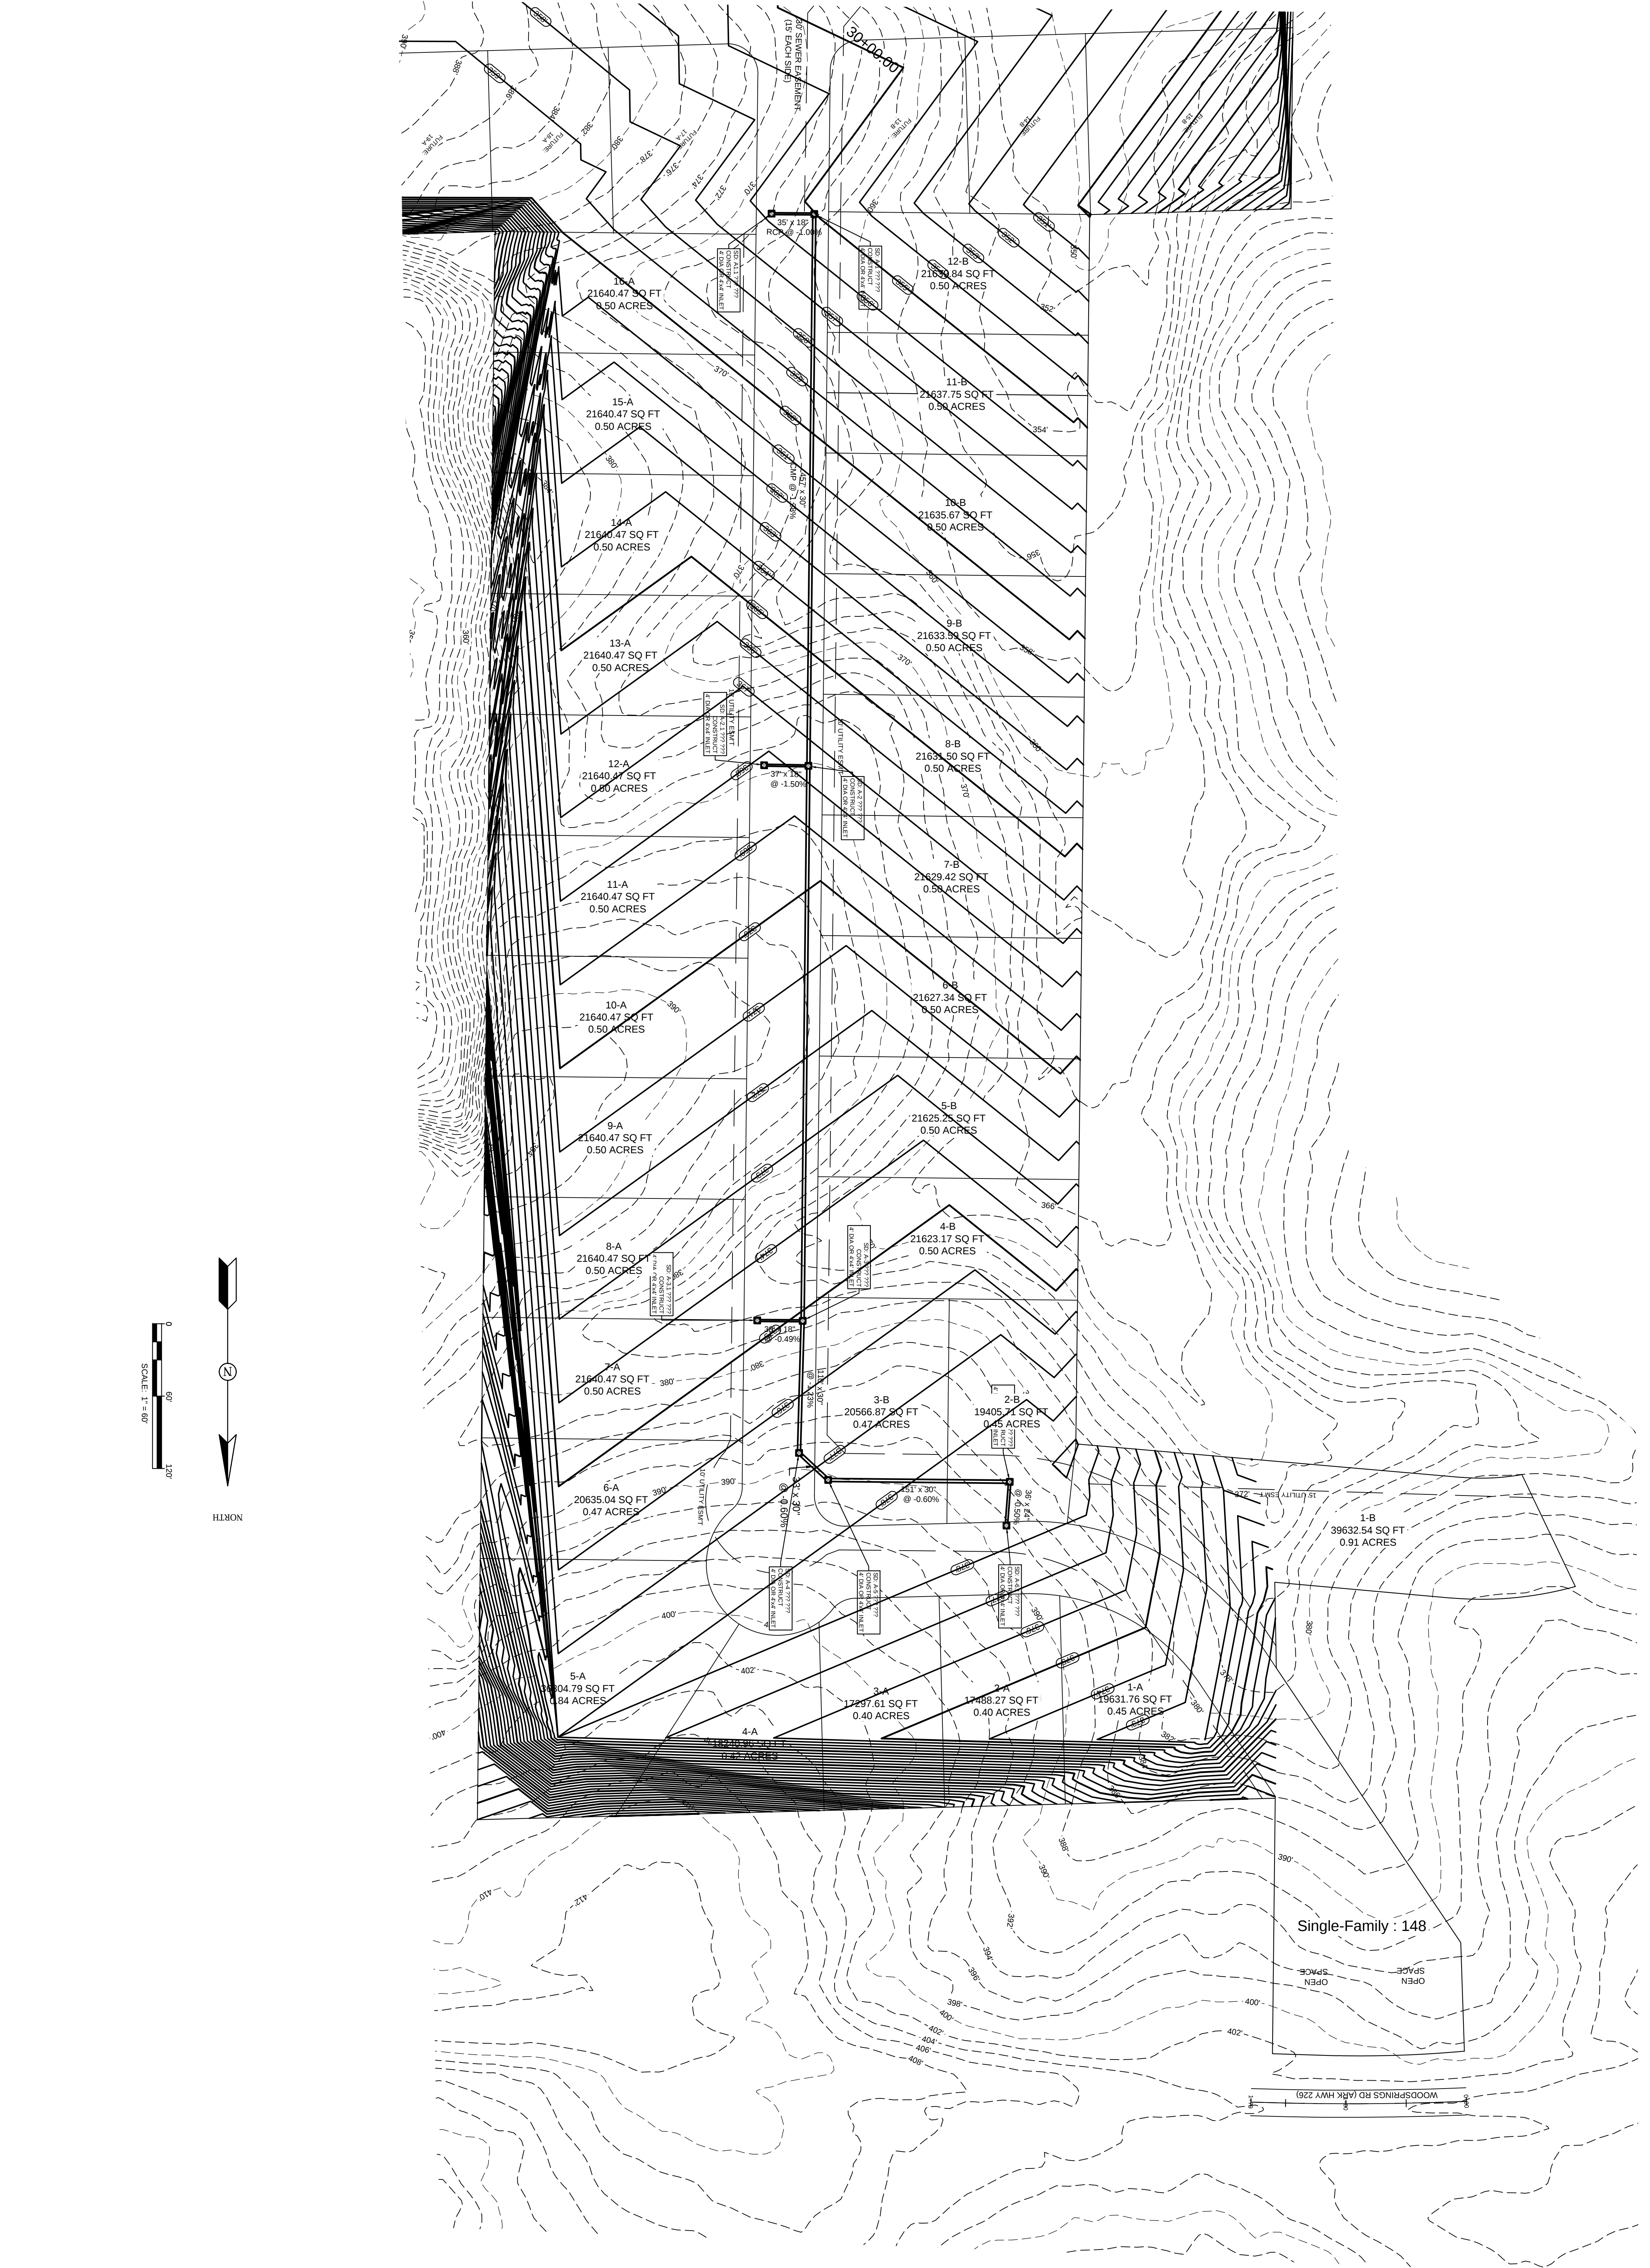

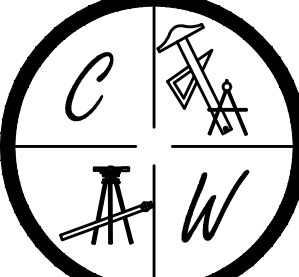

CARLOS WOOD, P.E.
ENGINEERING CONSULTANT

122 CR 375
BONO, AR 72416
PHONE/FAX: (870) 972-8335
EMAIL: WOODENGR@SBCGLOBAL.NET
WEBSITE: WWW.WOODENGR.COM

DRAWN BY: ECW

DATE: 5/7/15

REV:

LAKE POINTE PHASE I

JONESBORO, AR

TOPOGRAPHY &
DRAINAGE PLAN



STR-1